

PATRICK J. MORABITO
A.I.A.
ARCHITECT
P.C.

55 Sully's Trail
Pittsford, NY 14534

(585) 264-1330
(585) 264-1333 Fax

www.pjmarchitect.com

NOTICE:


IT IS A VIOLATION OF LAW FOR ANY PERSON UNLESS ACTING UNDER THE SUPERVISION OF A LICENSED ARCHITECT TO ALTER ANY ITEM ON THIS DOCUMENT IN ANY WAY.

ANY LICENSEE WHO ALTERS THIS DOCUMENT IS REQUIRED BY LAW TO FIX HIS OR HER SEAL AND THE NOTATION "ALTERED BY" FOLLOWED BY HIS OR HER SIGNATURE AND A SPECIFIC DESCRIPTION OF THE ALTERATIONS.

THESE DRAWINGS ARE COPYRIGHTED AND ARE SUBJECT TO COPYRIGHT PROTECTION AS AN "ARCHITECTURAL WORK" UNDER SEC. 102 OF THE COPYRIGHT ACT, 17 U.S.C. AS AMENDED (DECEMBER 1990 AND KNOWN AS ARCHITECTURAL WORKS COPYRIGHT PROTECTION ACT OF 1990). THE PROTECTION INCLUDES, BUT IS NOT LIMITED TO, THE OVERALL FORM AS WELL AS THE ARRANGEMENT AND COMPOSITION OF SPACES AND ELEMENTS OF THE DESIGN.

UNDER SOME PROTECTION, UNAUTHORIZED USE OF THESE DRAWINGS OR WORK REPRESENTED HEREIN CAN LEAD TO SUIT IN THE EVENT OF CONSTRUCTION OR BUILDING BEING SEIZED AND/OR MINORITY CONSTRUCTION TO PATRICK J. MORABITO, A.I.A. ARCHITECT P.C. NO FURTHER USE OR DISTRIBUTION IS ALLOWED WITHOUT THE WRITTEN PERMISSION AND CONSENT OF PATRICK J. MORABITO, A.I.A. ARCHITECT P.C.

COPYRIGHT 2012
 PATRICK J. MORABITO, A.I.A. ARCHITECT P.C.

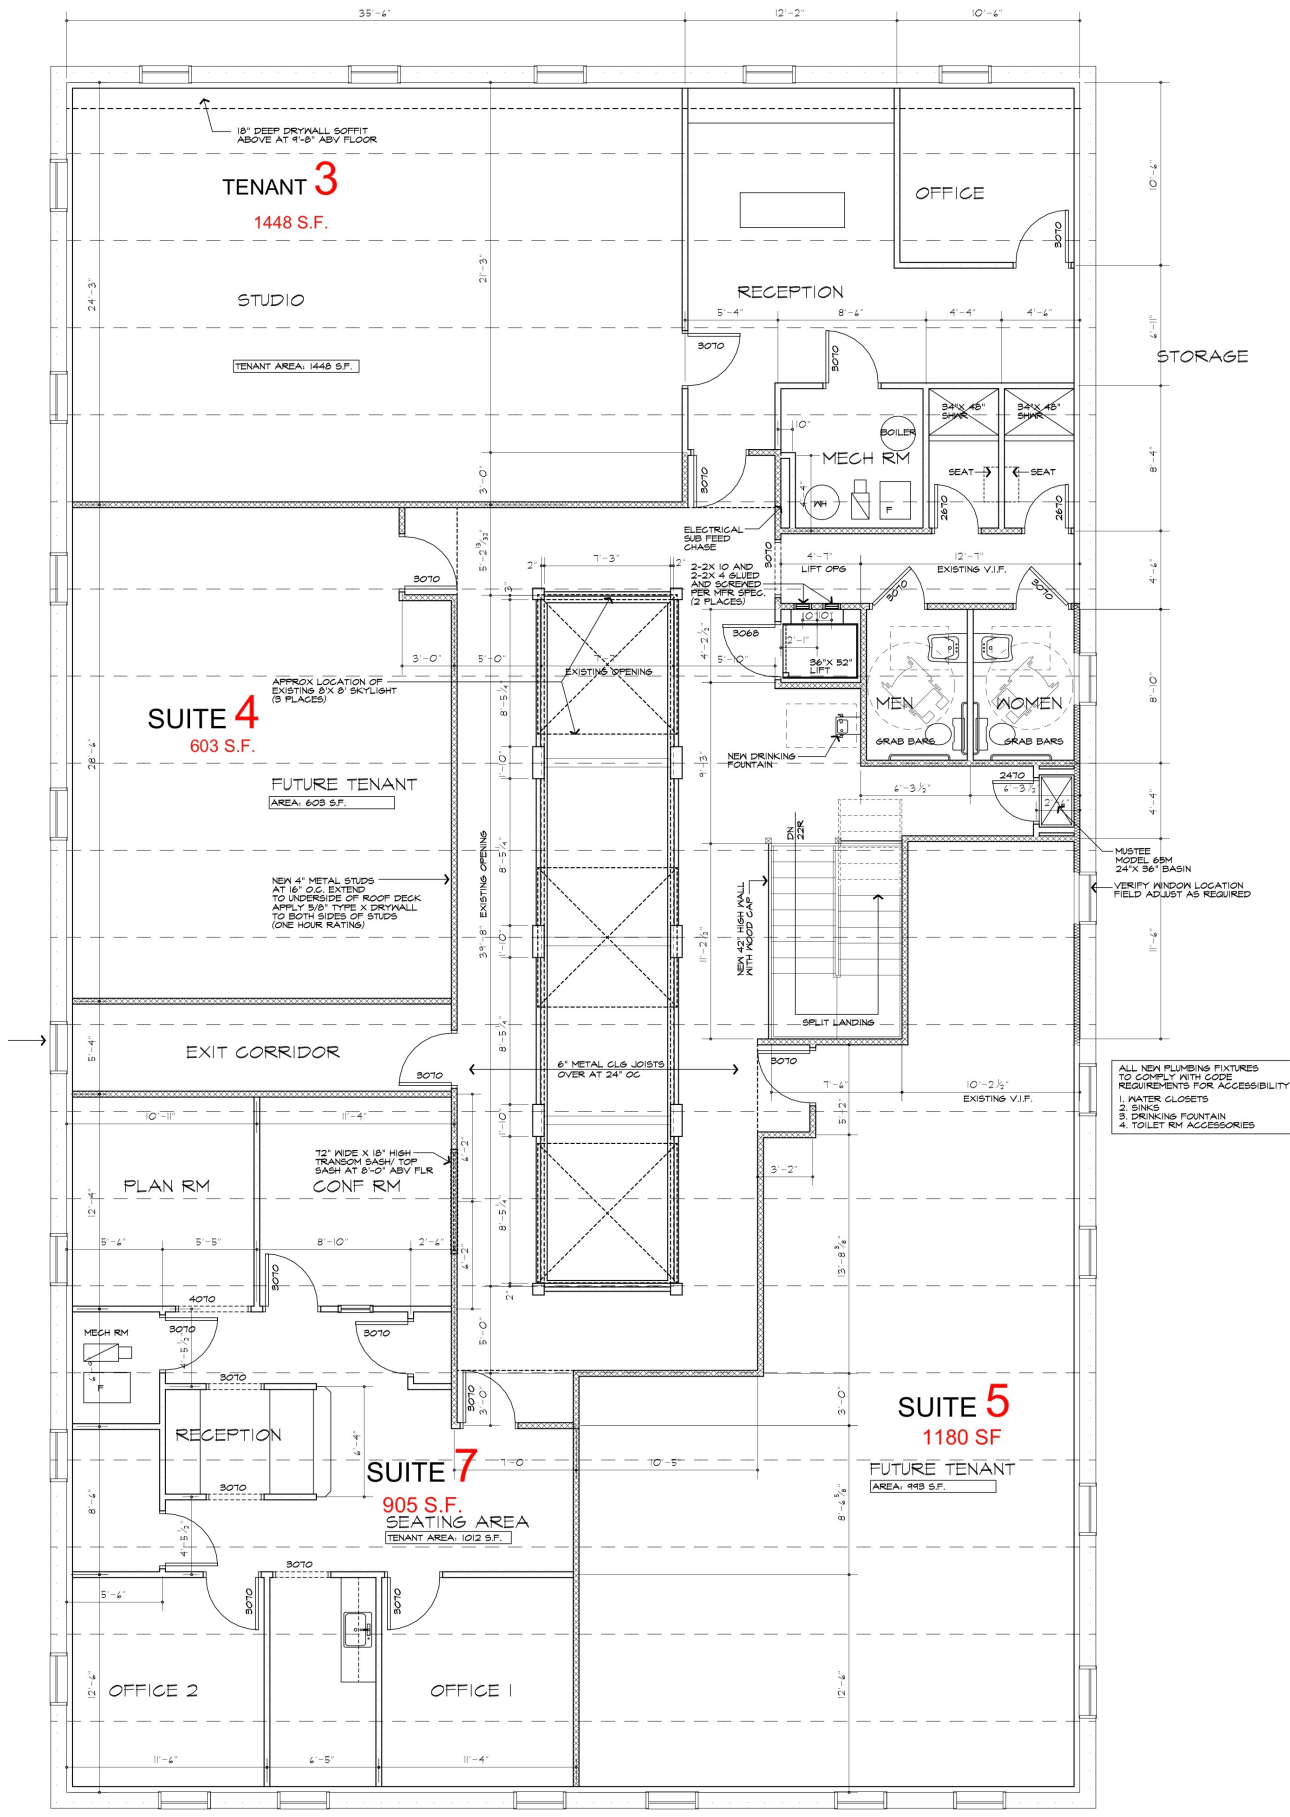

- ALL NEW PLUMBING FIXTURES TO COMPLY WITH CODE REQUIREMENTS FOR ACCESSIBILITY
1. WATER CLOSETS
 2. SINKS
 3. DRINKING FOUNTAIN
 4. TOILET RM ACCESSORIES

REVISED 11/24/2014 P.J.M.A.I.A.
 REVISED 1/14/2014 P.J.M.A.I.A.
 REVISED 10/21/2014 P.J.M.A.I.A.

PROJECT:
 RENOVATION TO 124 WEST COMMERCIAL STREET EAST ROCHESTER, NEW YORK.

CLIENT:
 JOSEPH L. GILMERBONE ENTERPRISES

DRAWING:
 2ND FLOOR PLAN PROPOSED

DRAWN: P.J.M.A.I.A.	CHECKED: PM
-------------------------------	-----------------------

DATE: 04/11/2013

SCALE: AS NOTED

JOB NO.: 124B/14T

SHEET:

2

OF 4 SHEETS



SECOND FLOOR PLAN/ PROPOSED